 


FLOOR PLAN



- 120 VAC
- 120 VAC WITH DUAL USB PORTS
- 120 VAC G.F.I.
- INVERTER
- 12 VDC
- SPARE PLATE
- RJ-45 NETWORK JACK
- RJ-11 TELEPHONE JACK

- HDMI PORT
- VGA PORT
- DB9 JACK
- DB15 JACK
- SPEAKER VOLUME
- TV ANTENNA
- SWITCH

- SURVEILLANCE CAMERA
- EXTERIOR 120 VAC G.F.I.
- CO/SMOKE DETECTOR
- SPEAKER

- POWER ROOF VENT

SOME ITEMS SHOWN MAY BE CUSTOMER SUPPLIED OR OPTIONAL. REFER TO SPECIFICATIONS FOR DETAILS.


THIS DRAWING AND THE INFORMATION THEREON IS THE EXCLUSIVE PROPERTY OF LDV, INC. AND IS TO BE USED SOLELY FOR DEVELOPMENT AND MANUFACTURE OF THE PRODUCT SHOWN. ALL RIGHTS RESERVED IN U.S. COPYRIGHT LAW.

REVISIONS			
NO.	DESCRIPTION	DATE	BY
1	ADD EXTERIOR LOCKER, 11'-8" MAX HT.	03.18.16	KRG
2	EXTEND COUNTER DEPTH @ STREET SIDE SLIDE-OUT	04.19.16	KRG
3			
4			
5			
6			
7			
8			




SPARKS PD (NV)
T34SWTEEQ-10

DRAWN BY K. GONZALEZ	DATE 03.09.16	SCALE 1/4" = 1'-0"
PROJECT MGR.	DATE	DWG. TYPE: PROPOSAL
DRAWING REFERENCE SALES		

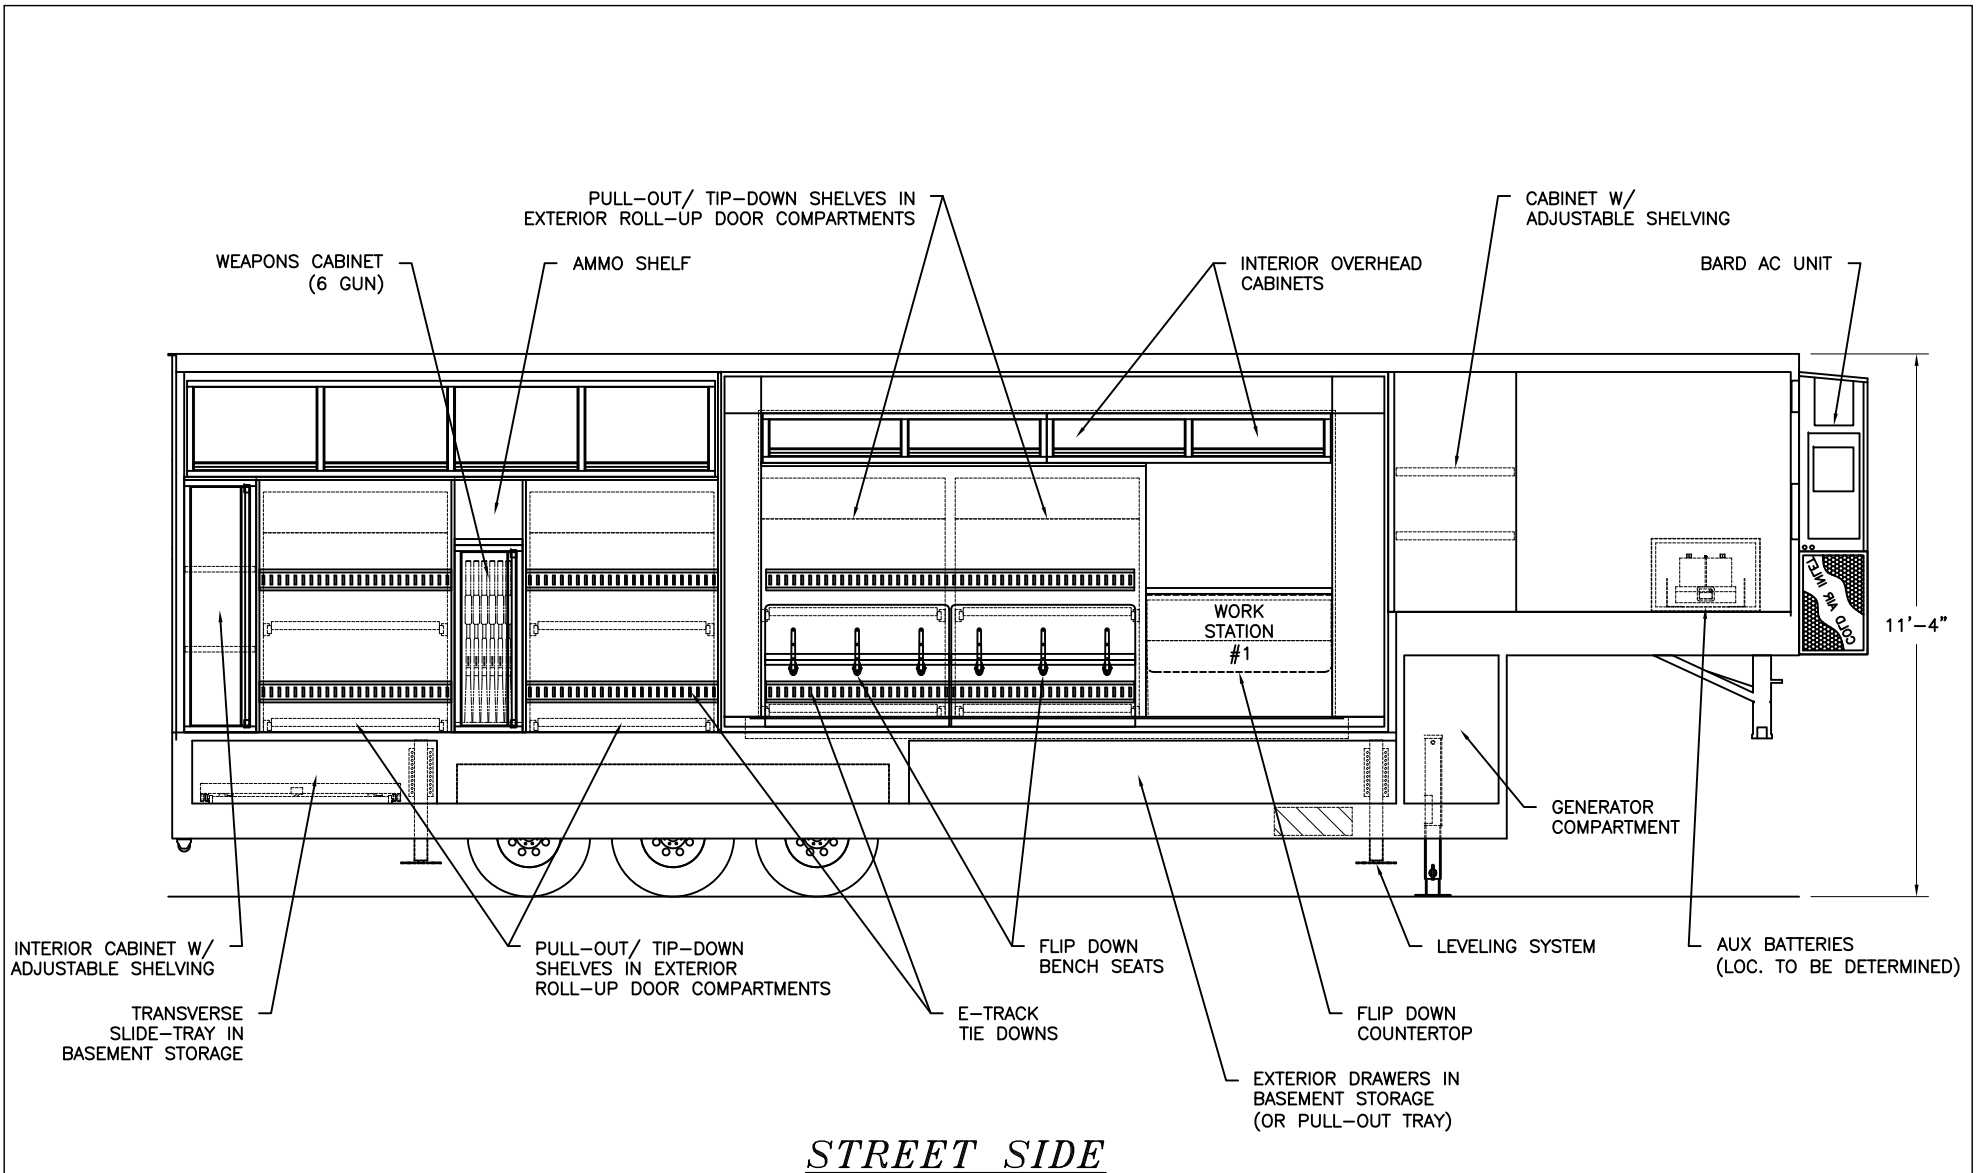

STREET SIDE

 

	120 VAC		HDMI PORT		SURVEILLANCE CAMERA		POWER ROOF VENT
	120 VAC WITH DUAL USB PORTS		VGA PORT		EXTERIOR 120 VAC G.F.I.		
	120 VAC G.F.I.		DB9 JACK		CO/SMOKE DETECTOR		
	INVERTER		DB15 JACK		SPEAKER VOLUME		
	12 VDC		TV ANTENNA		SPEAKER		
	SPARE PLATE		SWITCH				
	RJ-45 NETWORK JACK						
	RJ-11 TELEPHONE JACK						

SOME ITEMS SHOWN MAY BE CUSTOMER SUPPLIED OR OPTIONAL. REFER TO SPECIFICATIONS FOR DETAILS.


THIS DRAWING AND THE INFORMATION THEREON IS THE EXCLUSIVE PROPERTY OF LDV, INC. AND IS TO BE USED SOLELY FOR DEVELOPMENT AND MANUFACTURE OF THE PRODUCT SHOWN. ALL RIGHTS RESERVED IN U.S. COPYRIGHT LAW.

REVISIONS			
NO.	DESCRIPTION	DATE	BY
1	ADD EXTERIOR LOCKER, 11'-8" MAX HT.	03.18.16	KRG
2	EXTEND COUNTER DEPTH @ STREET SIDE SLIDE-OUT	04.19.16	KRG
3			
4			
5			
6			
7			
8			


LDV

SPARKS PD (NV)
T34SWTEEQ-10

DRAWN BY K. GONZALEZ	DATE 03.09.16	SCALE 1/4" = 1'-0"
PROJECT MGR.	DATE	DWG. TYPE PROPOSAL
DRAWING REFERENCE SALES		

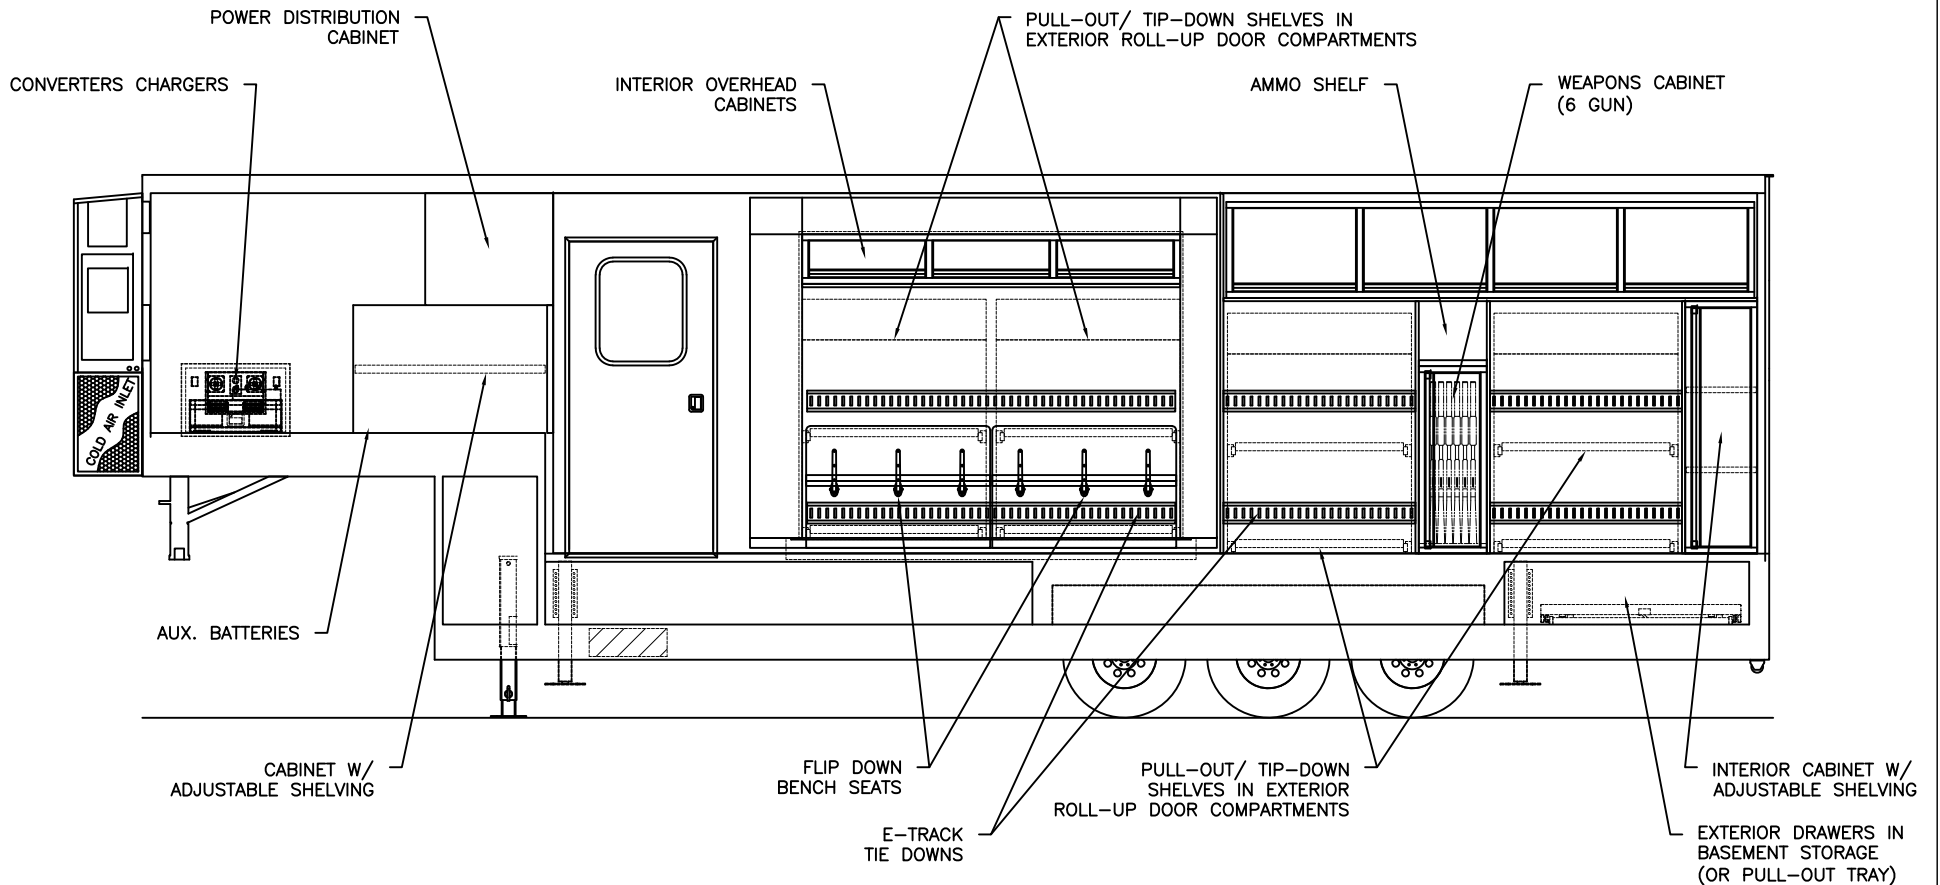

CURB SIDE

 

- 120 VAC
- 120 VAC WITH DUAL USB PORTS
- 120 VAC G.F.I.
- INVERTER
- 12 VDC
- SPARE PLATE
- RJ-45 NETWORK JACK
- RJ-11 TELEPHONE JACK

- HDMI PORT
- VGA PORT
- DB9 JACK
- DB15 JACK
- SPEAKER VOLUME
- TV ANTENNA
- SWITCH

- SURVEILLANCE CAMERA
- EXTERIOR 120 VAC G.F.I.
- CO/SMOKE DETECTOR
- SPEAKER



SOME ITEMS SHOWN MAY BE CUSTOMER SUPPLIED OR OPTIONAL. REFER TO SPECIFICATIONS FOR DETAILS.


THIS DRAWING AND THE INFORMATION THEREON IS THE EXCLUSIVE PROPERTY OF LDV, INC. AND IS TO BE USED SOLELY FOR DEVELOPMENT AND MANUFACTURE OF THE PRODUCT SHOWN. ALL RIGHTS RESERVED IN U.S. COPYRIGHT LAW.

REVISIONS			
NO.	DESCRIPTION	DATE	BY
1	ADD EXTERIOR LOCKER, 11'-8" MAX HT.	03.18.16	KRG
2	EXTEND COUNTER DEPTH @ STREET SIDE SLIDE-OUT	04.19.16	KRG
3			
4			
5			
6			
7			
8			




SPARKS PD (NV)
T34SWTEEQ-10


DRAWN BY K. GONZALEZ	DATE 03.09.16	SCALE 1/4" = 1'-0"
PROJECT MGR.	DATE	DWG. TYPE PROPOSAL
DRAWING REFERENCE SALES		

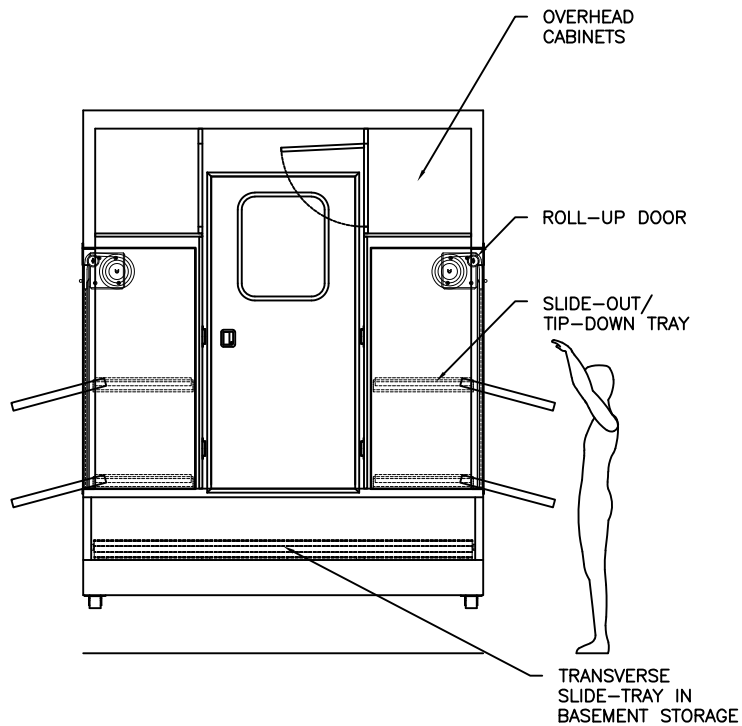

REAR

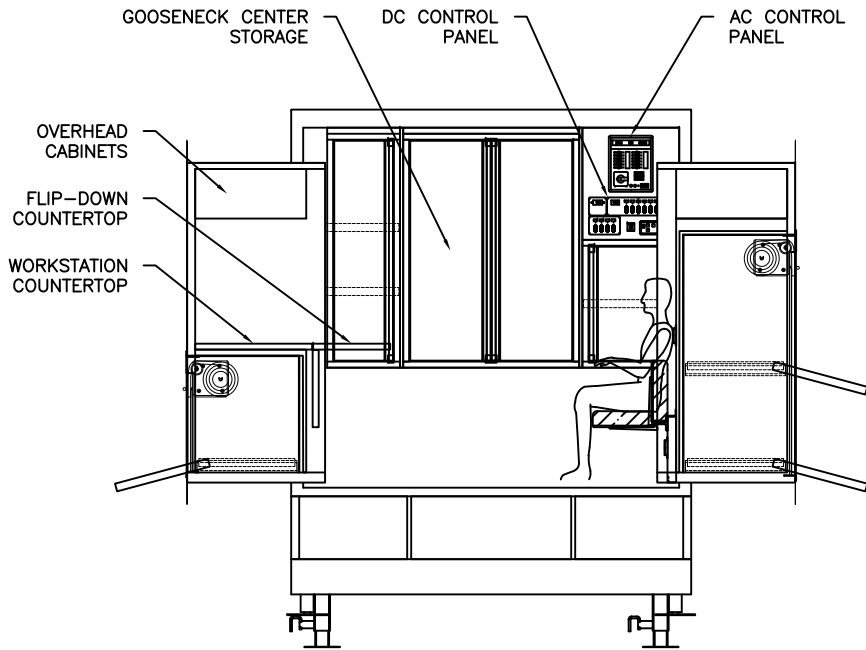

FRONT

 

120 VAC	HDMI PORT	SURVEILLANCE CAMERA	POWER ROOF VENT
120 VAC WITH DUAL USB PORTS	VGA PORT	EXTERIOR 120 VAC G.F.I.	
120 VAC G.F.I.	DB9 JACK	CO/SMOKE DETECTOR	
INVERTER	DB15 JACK	SPEAKER VOLUME	
12 VDC	TV ANTENNA	SPEAKER	
SPARE PLATE	SWITCH		
RJ-45 NETWORK JACK			
RJ-11 TELEPHONE JACK			

SOME ITEMS SHOWN MAY BE CUSTOMER SUPPLIED OR OPTIONAL. REFER TO SPECIFICATIONS FOR DETAILS.

THIS DRAWING AND THE INFORMATION THEREON IS THE EXCLUSIVE PROPERTY OF LDV, INC. AND IS TO BE USED SOLELY FOR DEVELOPMENT AND MANUFACTURE OF THE PRODUCT SHOWN. ALL RIGHTS RESERVED IN U.S. COPYRIGHT LAW.

REVISIONS			
NO.	DESCRIPTION	DATE	BY
1	ADD EXTERIOR LOCKER, 11'-8" MAX HT.	03.18.16	KRG
2	EXTEND COUNTER DEPTH @ STREET SIDE SLIDE-OUT	04.19.16	KRG
3			
4			
5			
6			
7			
8			



SPARKS PD (NV)
T34SWTEEQ-10

DRAWN BY K. GONZALEZ	DATE 03.09.16	SCALE 1/4" = 1'-0"
PROJECT MGR.	DATE	DWG. TYPE: PROPOSAL
DRAWING REFERENCE SALES		